


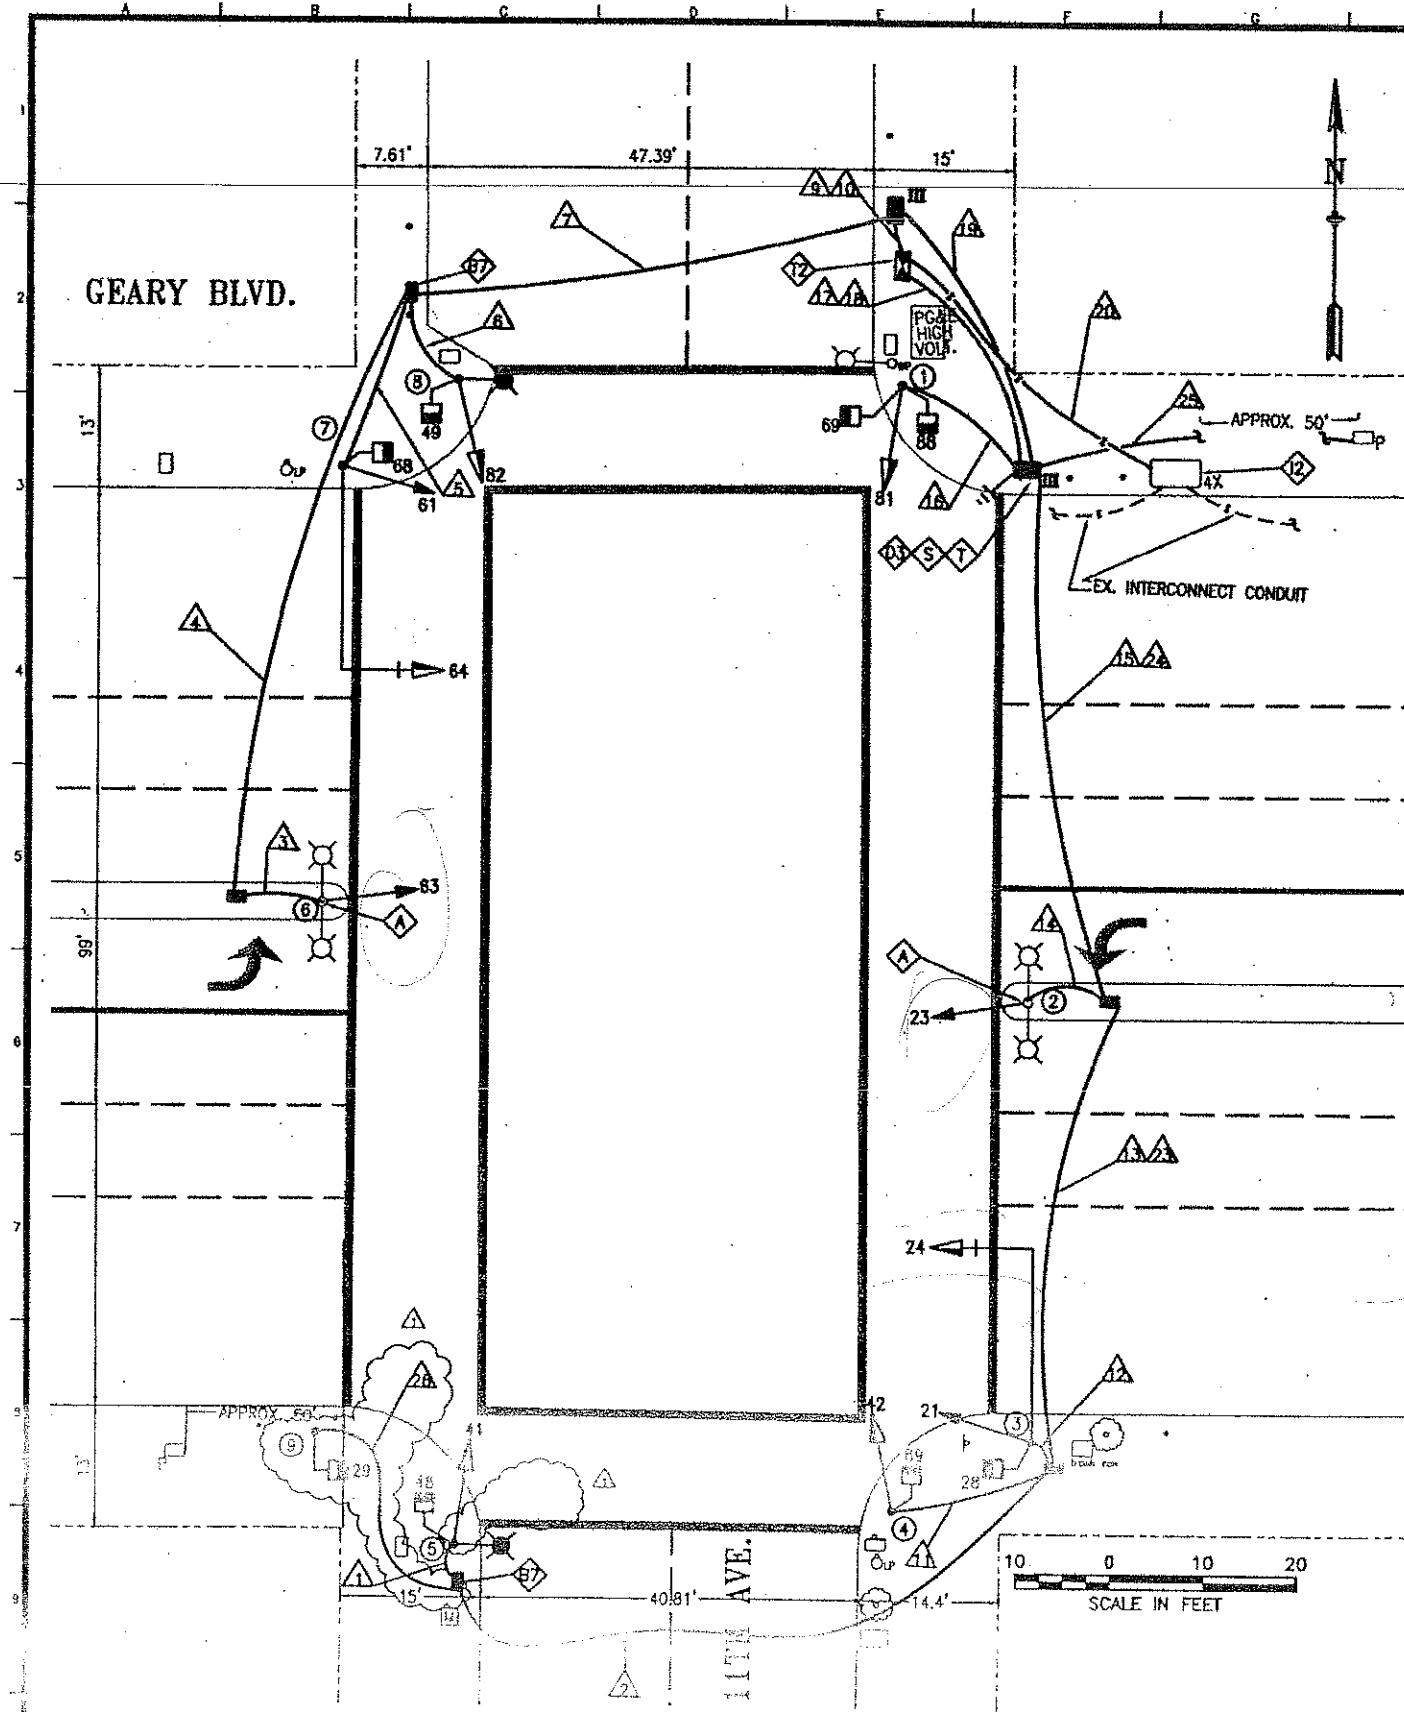

POLE AND EQUIPMENT SCHEDULE										CONTRACT WORK IN BOLD	
POLE No.	TYPE OF POLE	LUMINAIRE (HPS)	VEHICLE SIGNAL				PEDESTRIAN SIGNAL			REMARKS	
		VOLTAGE/WATTS	No.	TYPE	MOUNTING	VISORS	LOUVERS	No.	TYPE		
①	1-A (10')		81	3812"	TV-1-T	T		69	18-COUNT	SP-1-SF (12")	
								88	18-COUNT	SP-1 (22")	
②	EX SL (MARBLELITE)		23	388"	SV-1-T		T				
③	18-1-100 W/ 20' MASTARM		24	3812"	MAS	T		28	18-COUNT	SP-1	BACKPLATE
			21	388"	SV-1-T	T					
④	1-A (10')		42	3812"	TV-1-T	T		89	18-COUNT	SP-1	
⑤	CITY STANDARD STREET LIGHT	120 V/100 W	41	3812"	SV-1-T		T	48	18-COUNT	SP-1	
⑥	EX SL (MARBLELITE)		63	388"	SV-1-T		T				
⑦	18-1-100 W/ 20' MASTARM		84	3812"	MAS	T		68	18-COUNT	SP-1	BACKPLATE
			61	388"	SV-1-T	T					
⑧	CITY STANDARD STREET LIGHT	120 V/100 W	82	3812"	SV-1-T		T	49	18-COUNT	SP-1	
⑨	1-A (7')							29	18-COUNT	TP-1	

3-COR ACTIVATION ON 4/8/09 AT 10:20 AM

DETAIL NOTES:


- Ⓐ CHIP FOUNDATION CAREFULLY TO BRING CONDUIT INTO BASE OF STANDARD OR CONTROLLER CABINET AND REPAIR AFTER INSTALLATION.
- Ⓒ F/I FUSE AND FUSE HOLDER PER SPDWSF FILE 87203.
- Ⓓ SPICE NEW STREET LIGHT WIRING TO LINE SIDE OF PG&E SERVICE.
- Ⓔ SPICE NEW 12/C TO EX 12/C TO CONNECT NEW CONTROLLER TO EX INTERCONNECT SYSTEM.

- Ⓔ CONTRACTOR SHALL COORDINATE WITH PG&E VIA WALLY SUN OF HATCH HATCHY AT (415) 554-1873 FOR SERVICE CONNECTION WORK PRIOR TO START OF CONSTRUCTION.
- Ⓕ F/I IN-LINE FUSE HOLDER W/ 40 A FUSE FOR IC SERVICE.
- Ⓖ CONTRACTOR SHALL LABEL SERVICE CONDUCTORS IN THE IC CABINET TO IDENTIFY CORNER OF INTERSECTION WHERE IN-LINE FUSE HOLDER FOR IC SERVICE IS INSTALLED. (I.E. A SAMPLE LABEL IS AS FOLLOWS: "IC FUSE INSTALLED IN NE CORNER")

SHEET NOTE:

- 1. SEE DRAWING R-1 FOR CURB RAMP WORK.

PHASE DIAGRAM

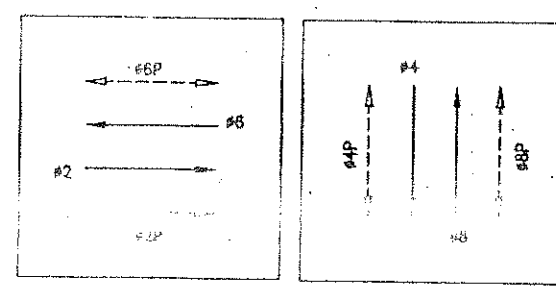


FLASHING OPERATIONS ACTIVATED ON 4/6/09 AT 12:10 PM. FY FOR GEARY AND FR FOR 11TH AVENUE. ATTENDED BY: GERARDINE DE LEON (CDPT), PHASE SEQUENCE TIM WOULD (DPW), AND LAURA MINTER (SIGNALS)

G	Y	R	GEARY BLVD. (EB & WB) - #2 & #6
R	G	Y	11TH AVE. (NB & SB) - #4 & #8
W	W	FRH	PED XING 11TH AVE. (SS & NS) - 2P & 8P
R	W	FRH	PED XING GEARY BLVD. (WS & ES) - 4P & 8P

NO.	DATE	DESCRIPTION	BY	APP.
1	6/20/09	POD #1: VARIOUS CHANGES BASED ON POLE LAYOUT	JC	SL



BUREAU OF ENGINEERING
DEPARTMENT OF PUBLIC WORKS
CITY AND COUNTY OF SAN FRANCISCO

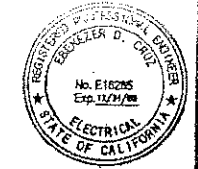

DESIGNED	DATE	APPROVED
GD	9/2007	
DRAWN	DATE	SECTION MANAGER
GD	9/2007	
CHECKED	DATE	DEPUTY BUREAU MANAGER
BC	9/2007	
		CITY ENGINEER

SCALED	AS SHOWN
SHEET OF SHEETS	16 OF 25

CONTRACT NO.	58
NEW TRAFFIC SIGNALS	
GEARY BOULEVARD AND 11TH AVENUE	
TRAFFIC SIGNAL WORK AND	
POLE & EQUIPMENT SCHEDULE	
SPECIFICATION NO.	1387J
DRAWING NO.	E-5.0
FILE NO.	87,621
REV. NO.	0

Drawing Title: GEARY BLVD. AND 11TH AVE. TRAFFIC SIGNALS
 Project No.: 060400
 Date: 9/2007
 Scale: 1" = 40' (Horizontal), 1" = 20' (Vertical)
 Author: J. C. [Name]
 Checker: B. C. [Name]
 Engineer: E. D. [Name]
 City Engineer: [Name]
 City Engineer: [Name]

[illegible]

1. SEE GROUNDING LAYOUT ⁵_{8-0.0} AND SECTION 02890 IN CONTRACT SPECIFICATIONS

NO.	DATE	DESCRIPTION	BY	APP
△	6/20/08	PCD #1: VARIOUS CHANGES BASED ON POLE LAYOUT	JC	SL
TABLE OF REVISIONS CHECK WITH TRACING TO SEE IF YOU HAVE LATEST REVISION				



SCALE:
NONE
SHEET OF SHEETS
17 OF 25

SPECIFICATION NO.	1387J
DRAWING NO.	E-5.1
FILE NO.	87,622
REV. NO.	

[illegible]