

POLE AND EQUIPMENT SCHEDULE											
POLE No.	TYPE OF POLE	FIXTURE TYPE <div>B</div>	VEHICLE SIGNAL					PEDESTRIAN SIGNAL			REMARKS <div>A</div>
			No.	TYPE	MOUNTING	VISORS	LV/BP	No.	TYPE	MOUNTING	
①	17-3-100 POLE WITH 15-FT MAST ARM AND 6-FT LUMINAIRE ARM	<div>S0107</div>	46 81 84	3S12" 3S12" 3S12" <div>1</div>	SV-2-TA MAC	T T T	 BP	88	1S-COUNT	SP-1	APS
②	STEEL STREETLIGHT	<div>S1107</div>	52	5S12"YGLA	SV-1-T	T		69	1S-COUNT	SP-1	APS
③	17-3-100 POLE WITH 15-FT MAST ARM AND 6-FT LUMINAIRE ARM	<div>S0107</div>	21 54	3S12" 5S12"YGLA	SV-1-T MAC	T T	 BP	28	1S-COUNT	SP-1	APS
④	1-A (10')		42 85	3S12" 3S12"	TV-2-T	T		89	1S-COUNT	SP-1	APS
⑤	STEEL STREETLIGHT	<div>S1107</div>	36 91	3S12" LA 4S12" GRA	SV-2-TA	T T		108	1S-COUNT	SP-1	APS
⑥	STEEL STREETLIGHT	<div>S1107</div>	62	3S12"	SV-1-T	T		29	1S-COUNT	SP-1	APS
⑦	(E) 24-3-100 POLE WITH 35-FT MAST ARM AND 6-FT LUMINAIRE ARM	(E) 105W	(E) 32 (E) 61 (E) 64	(E) 3S12" LA (E) 3S12" (E) 3S12"	(E) SV-2-TA (E) MAS	(E) T (E) T (E) T	(E) BP (E) BP	(E) 109	(E) 1S-COUNT	(E) SP-1	APS
⑧	(E) 17-2-100 POLE WITH 15-FT MAST ARM AND 6-FT LUMINAIRE ARM	(E) 105W	(E) 34 (E) 95	(E) 3S12" LA (E) 4S12" GRA	(E) MAS (E) SV-1-T	(E) T (E) T	(E) BP	(E) 68	(E) 1S-COUNT	(E) SP-1	APS


GENERAL NOTES

1. MAINTAIN ALL EXISTING STREETLIGHT CIRCUITS U
2. ROUTE PUSH BUTTON THROUGH EXISTING TRAFF

SHEET NOTES

- A CONTRACTOR TO PROVIDE APS WIRING. CITY FOR REQUIREMENTS.
- B SEE ET-0.4 FOR LIGHTING FIXTURE SCHEDULE
- C POLE IN PLACE OF POLE. PROVIDE TEMPORARY
- D COUPLE TO EXISTING STUBBED CONDUITS AT TR
- E EXACT PG&E SERVICE LOCATION AND CITY SERV TO BE WITHIN 5' OF PG&E SERVICE.
- F CONTRACTOR TO MAINTAIN EXISTING STREETLIGHT
- G CONTRACTOR SHALL HAVE THE OPTION TO RE-

PHASE DIAGRAM

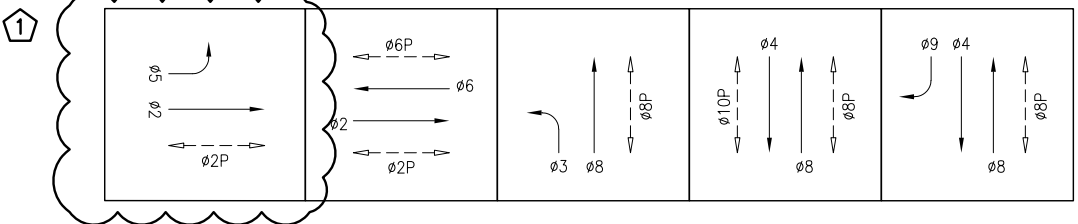

Signal modification work was completed on 04/25/2023 at Harrison at Main as part of 1000007916(R) Harrison Street Improvement Project.

Approximate times only.
Signal Dark 11:30 pm
Signal 3 Color 12:00 pm

Attendees:
Daniel Padilla (SFMTA SSD)
Niall O'Flynn (Bay Area Lightworks)
Phong Nguyen SFMTA Signal Shop
Leonard Wong SFMTA Signal Shop
Brian Wong (SF Public Works)

1 01/13/22 PCO#10 ADD PHASE 5 MT/MA DP/GL		REFERENCE INFORMATION & FILE NO. OF SURVEYS		BUREAU OF ENGINEERING CITY & COUNTY OF SAN FRANCISCO SAN FRANCISCO PUBLIC WORKS 49 SOUTH VAN NESS AVENUE, 8TH FLOOR SAN FRANCISCO, CA 94103		Acting Section Mgr: KENNY CHIN Acting Deputy Bureau Mgr: LESLEY WONG Acting Bureau Mgr: IOBAL DHAPA		DESIGNED: MT/DG 03/2020 DRAWN: MT/DG 03/2020 CHECKED: DP/SL 03/2020		SCALE: AS SHOWN SHEET OF SHEETS 126 OF 150		HARRISON STREET IMPROVEMENT PROJECT MAIN STREET AND HARRISON STREET TRAFFIC SIGNAL PLAN		CONTRACT NO. 1000007916(R) DRAWING NO. ET-3.1 FILE NO. 116,039(R) REV. NO. 1	
---	--	---	--	---	--	---	--	---	--	---	--	--	--	---	--

