

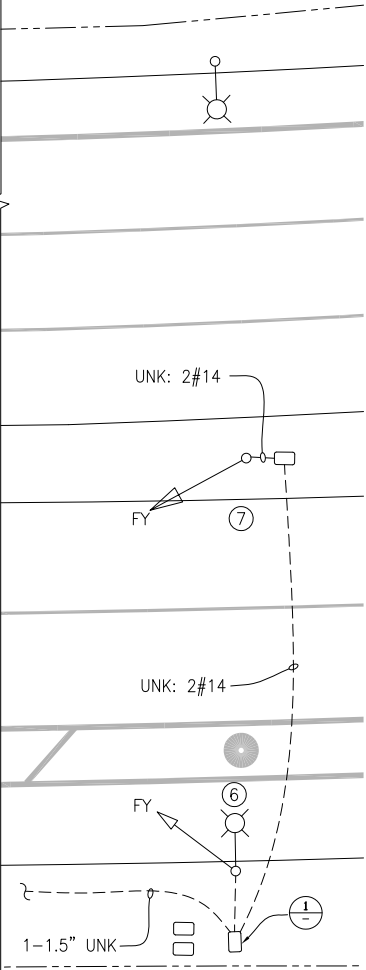


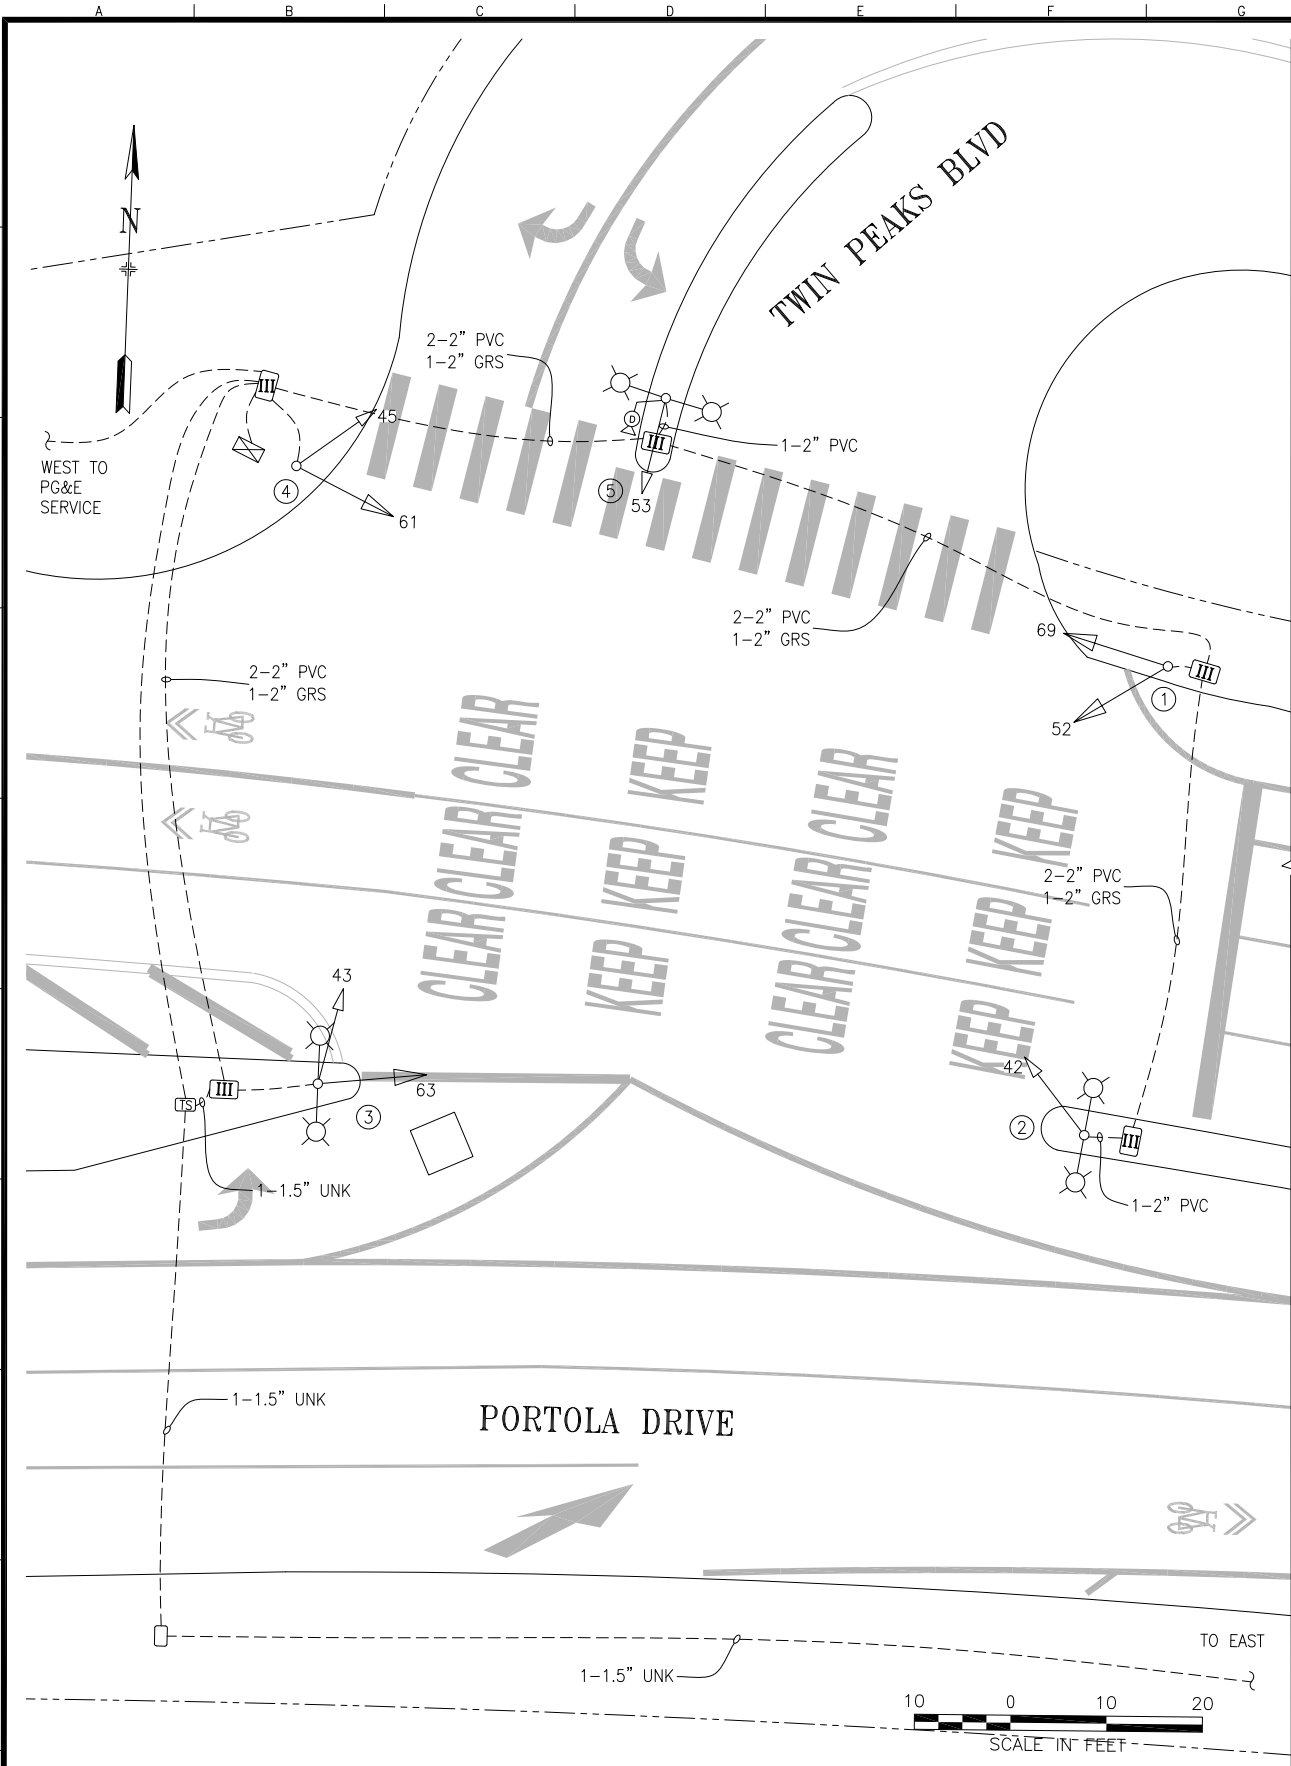

POLE AND EQUIPMENT SCHEDULE										
POLE No.	TYPE OF POLE	VEHICLE SIGNAL					PEDESTRIAN SIGNAL			REMARKS
		No.	TYPE	MOUNTING	VISORS	LOUVERS/BP	No.	TYPE	MOUNTING	
①	MARBELITE (10')	52 69	3S12" 3S12"	TV-2-T-SFA	T T					
②	ORTHOGONAL CONCRETE STREETLIGHT WITH DUAL 6' LUMINAIRE ARMS	42	3S8"	CUSTOM	FC					EXTERNAL CONDUIT
③	ORTHOGONAL CONCRETE STREETLIGHT WITH DUAL 6' LUMINAIRE ARMS	43 63	3S8" 3S12"	SV-1 SV-1	FC FC					
④	ORTHOGONAL MARBELITE (10')	45 61	3S8" 3S12"	TV-2-T	FC FC					
⑤	ORTHOGONAL CONCRETE STREETLIGHT WITH DUAL 6' LUMINAIRE ARMS	53	3S8"	CUSTOM	FC					EXTERNAL CONDUIT DETECTION CAMERA
⑥	ORTHOGONAL CONCRETE STREETLIGHT WITH 6' LUMINAIRE ARM	FY	3S8"	SV-1	FC					3S8" MIDDLE SECTION EMPTY
⑦	1-A (10')	FY	3S12"	TV-1-T	T					3S12" MIDDLE SECTION EMPTY

① FLASHING YELLOW SINGLE LINE DIAGRAM
- NOT TO SCALE

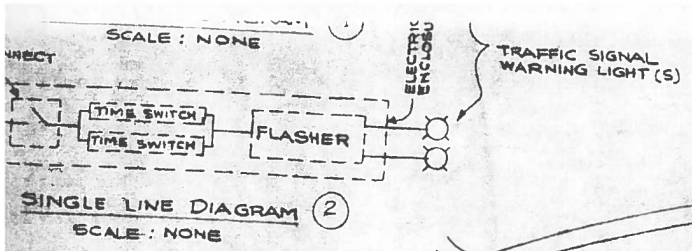

01/19/23	SHOP MAINTENANCE: UPGRADE 52 AND 69 TO 3S12" AFTER DAMAGE. CONVERTED FROM MSID, CT-2821J CONTRACT PLANS, & PER FIELD.	C. SKERRIT	G. DELEON		
NO.	DATE	DESCRIPTION	BY	APPROVED	
TABLE OF REVISIONS CHECKOUT DRAWING THROUGH THE SID CUSTODIAN FOR THE LATEST REVISION					



SFMTA

DRAWN BY: C. SKERRIT	DATE: 02/03/2023
CHECKED BY: G. DELEON	DATE: 02/06/2023

SCALE AS SHOWN
SHEET OF SHEETS 01 OF 01

TRAFFIC SIGNAL INVENTORY DIAGRAM
PORTOLA DRIVE & TWIN PEAKS BOULEVARD

CNN NO: 22435000
REV NO: 0