


\\CHS-FILES\CHS-Files\Projects\2014\Mission Bay Blocks 29-32 and 33-34 Plans - 14-1026\Blocks 29-32\CADD\MB 29-32 - Warriors - Bost2.2-2.4 29-32.dwg 04_30_2019 9:35am BY: blee

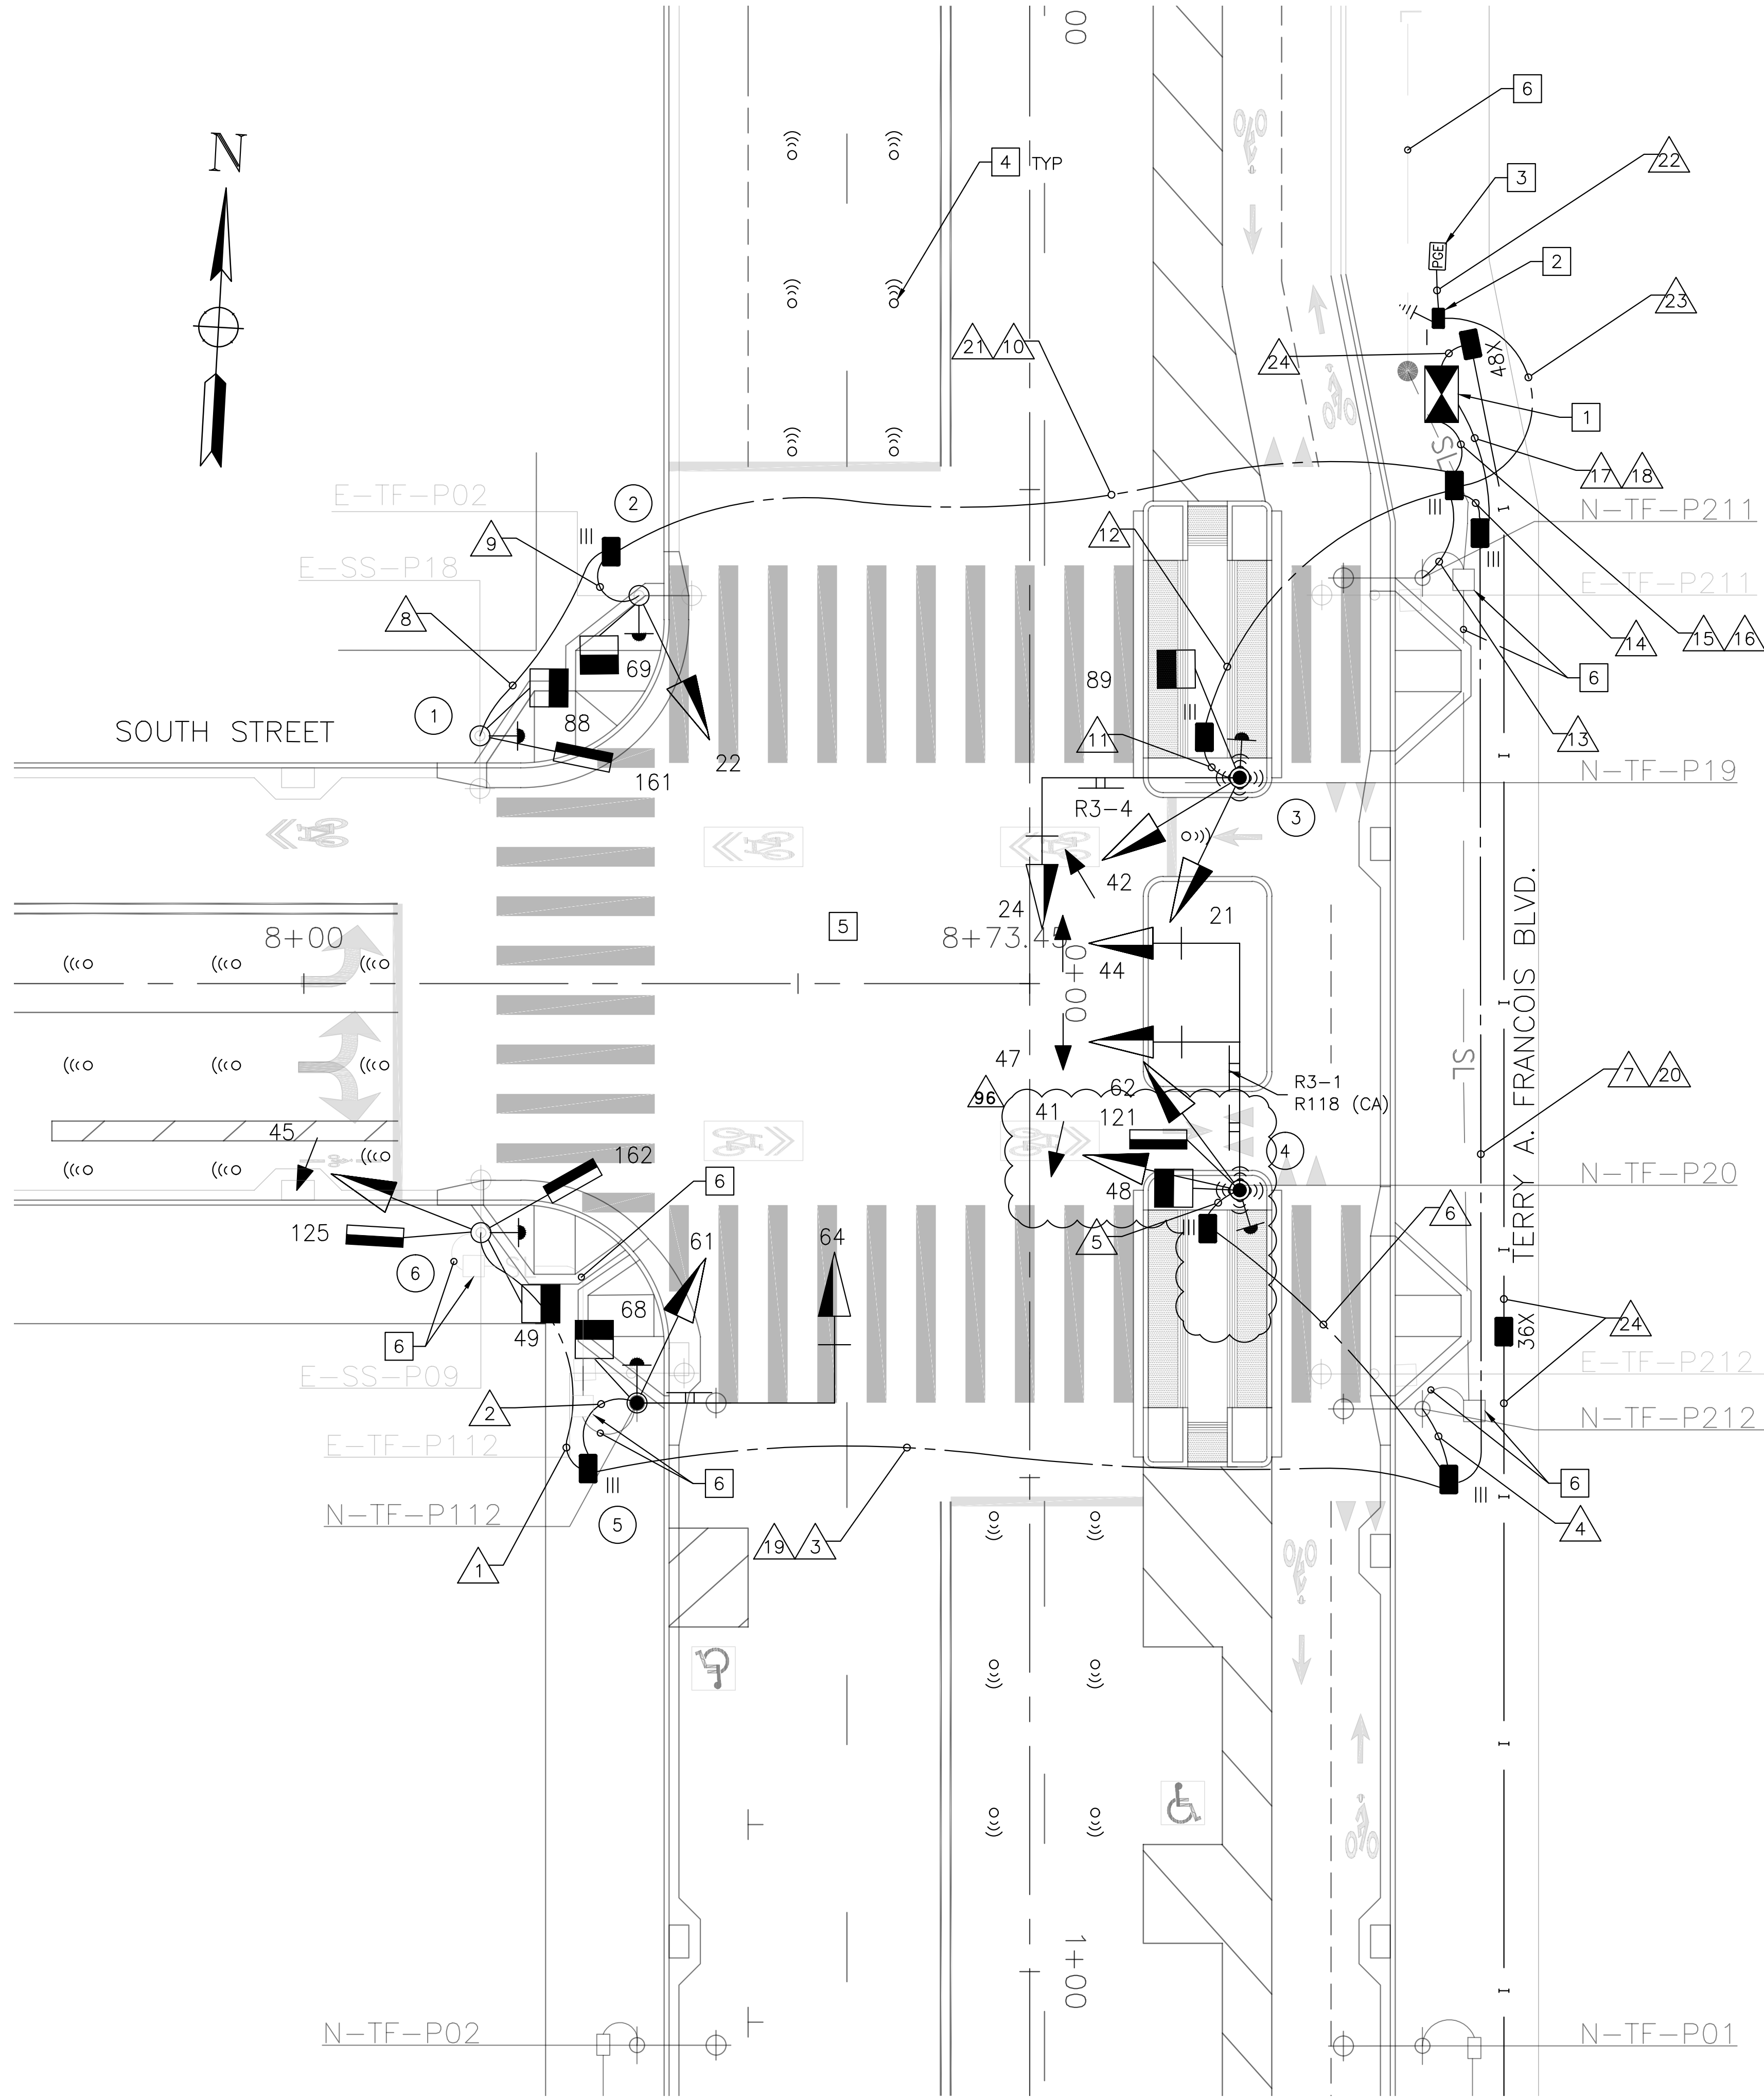

SHEET NOTES

- 1 CONTRACTOR TO INSTALL TYPE 2070 CONTROLLER ASSEMBLY AND CABINET. MTA TO FURNISH M-SF CABINET AND CONTROLLER WITH BATTERY BACKUP. THE CONTRACTOR SHALL ALSO FURNISH THE ANCHOR BOLTS AND CONSTRUCT THE CONTROLLER CABINET FOUNDATION - SEE SPECIFICATIONS FOR THE CONTROLLER ASSEMBLY AND CCSF "M-SF" CABINET FOUNDATION REQUIREMENTS. LOCATION OF CABINET TO BE IDENTIFIED PER FIELD MEETING WITH SFMTA AND LOCATED 30" FROM BACK OF CABINET TO FACE OF CURB.
- 2 CONTRACTOR TO PROVIDE 40A INLINE FUSE AND FUSE HOLDER FOR TRAFFIC SIGNAL SERVICE DISCONNECT IN THE FIRST PULL BOX NEXT TO THE NEW PG&E SERVICE.
- 3 PG&E (040937) PULL BOX (SEE MB BLOCKS 29-32 JOINT TRENCH PLAN E3.2).
- 4 SENSYS DETECTORS TO BE PURCHASE AND INSTALLED BY CITY FORCES.
- 5 POLE LAYOUT MEETING WITH TRAFFIC SIGNAL SHOP & TRAFFIC ENGINEER REQUIRED PRIOR TO POLE FOUNDATION CONSTRUCTION.
- 6 STREET LIGHT PULL BOX AND WIRING PER MB BLOCK 29-32 LIGHTING PLAN E2.1.


FLASH 8/28/2019 (11:25AM)

SFMTA
Wei Zhang
Karim Moradi
Cynthia Hui
Steven Wong
Stephanie Chan

3-COLOR 8/30/2019 (11:20AM)

SFMTA
Karim Moradi
Michael Bourne

PHASE DIAGRAM (STEADY DEMAND)

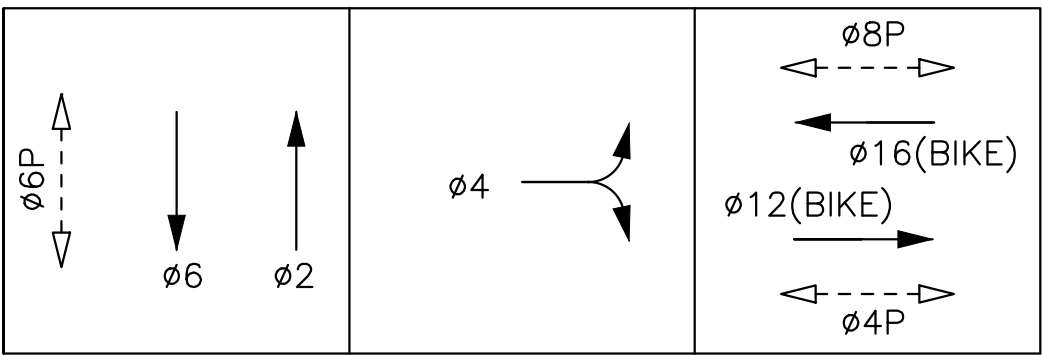

1"=10'

THIS PLAN IS ACCURATE FOR ELECTRICAL WORK ONLY

DATE: 8/3/18
DESIGNED: BL
DRAWN: BL
CHECKED: SK
PROJ. ENGR: SK
SCALE: 1"=10'
BAR IS ONE INCH ON ORIGINAL
NOT ONE INCH ON THIS SHEET.
ADJUST SCALE ACCORDINGLY

SHEET
T2.4

JOB NO.
42037C

FREYER & LAURETA, INC.
144 North San Mateo Drive
San Mateo, CA 94401
(650)344-9901 • Fax: (650)344-9920 • www.freyerlaureta.com
SUBCONSULTANT:
Consulting Group
144 North San Mateo Drive
San Francisco, CA 94104
(415) 392-9888

MISSION BAY DEVELOPMENT GROUP
MBDG

MISSION BAY DEVELOPMENT GROUP

SIP PERMIT SET	DATE
INSTRUCTIONAL BULLETIN #7 A	8/30/18
INSTRUCTIONAL BULLETIN #7.1A	8/3/18
REF #98-SCOPE 5 A	4/29/19

TRAFFIC SIGNAL
SOUTH ST AT TERRY A.
FRANCOIS BLVD
MISSION BAY BLOCKS 29-32
MISSION BAY PROJECT, SAN FRANCISCO, CA

96

96

1

2

3

4

5

6

South St

Terry A. Francois

DETAIL B



FL FREYER & LAURETA, INC.


CIVIL ENGINEERS • SURVEYORS • CONSTRUCTION MANAGERS
144 North San Mateo Drive • San Mateo, CA 94401
(650)344-9901 • Fax (650)344-9920 • www.freyriaureta.com

chs Consulting Group
220 MONTGOMERY STREET, SUITE 346
SAN FRANCISCO, CA 94104
(415) 392-9688

SUBCONSULTANT:

220 MONTGOMERY STREET, SUITE 346
SAN FRANCISCO, CA 94104
(415) 392-9688

**MISSION
BAY
DEVELOPMENT
GROUP**

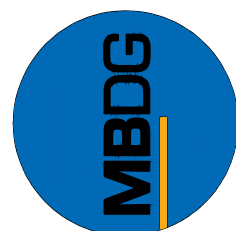

TRAFFIC SIGNAL EQUIPMENT AND
CONDUCTOR SCHEDULES - SOUTH ST
AT TERRY FRANCOIS BLVD
MISSION BAY BLOCKS 29-32
MISSION BAY PROJECT, SAN FRANCISCO, CA

[illegible]